



REVISION HISTORY			
REV	DESCRIPTION	DATE	APPROVED

DETAIL "E"

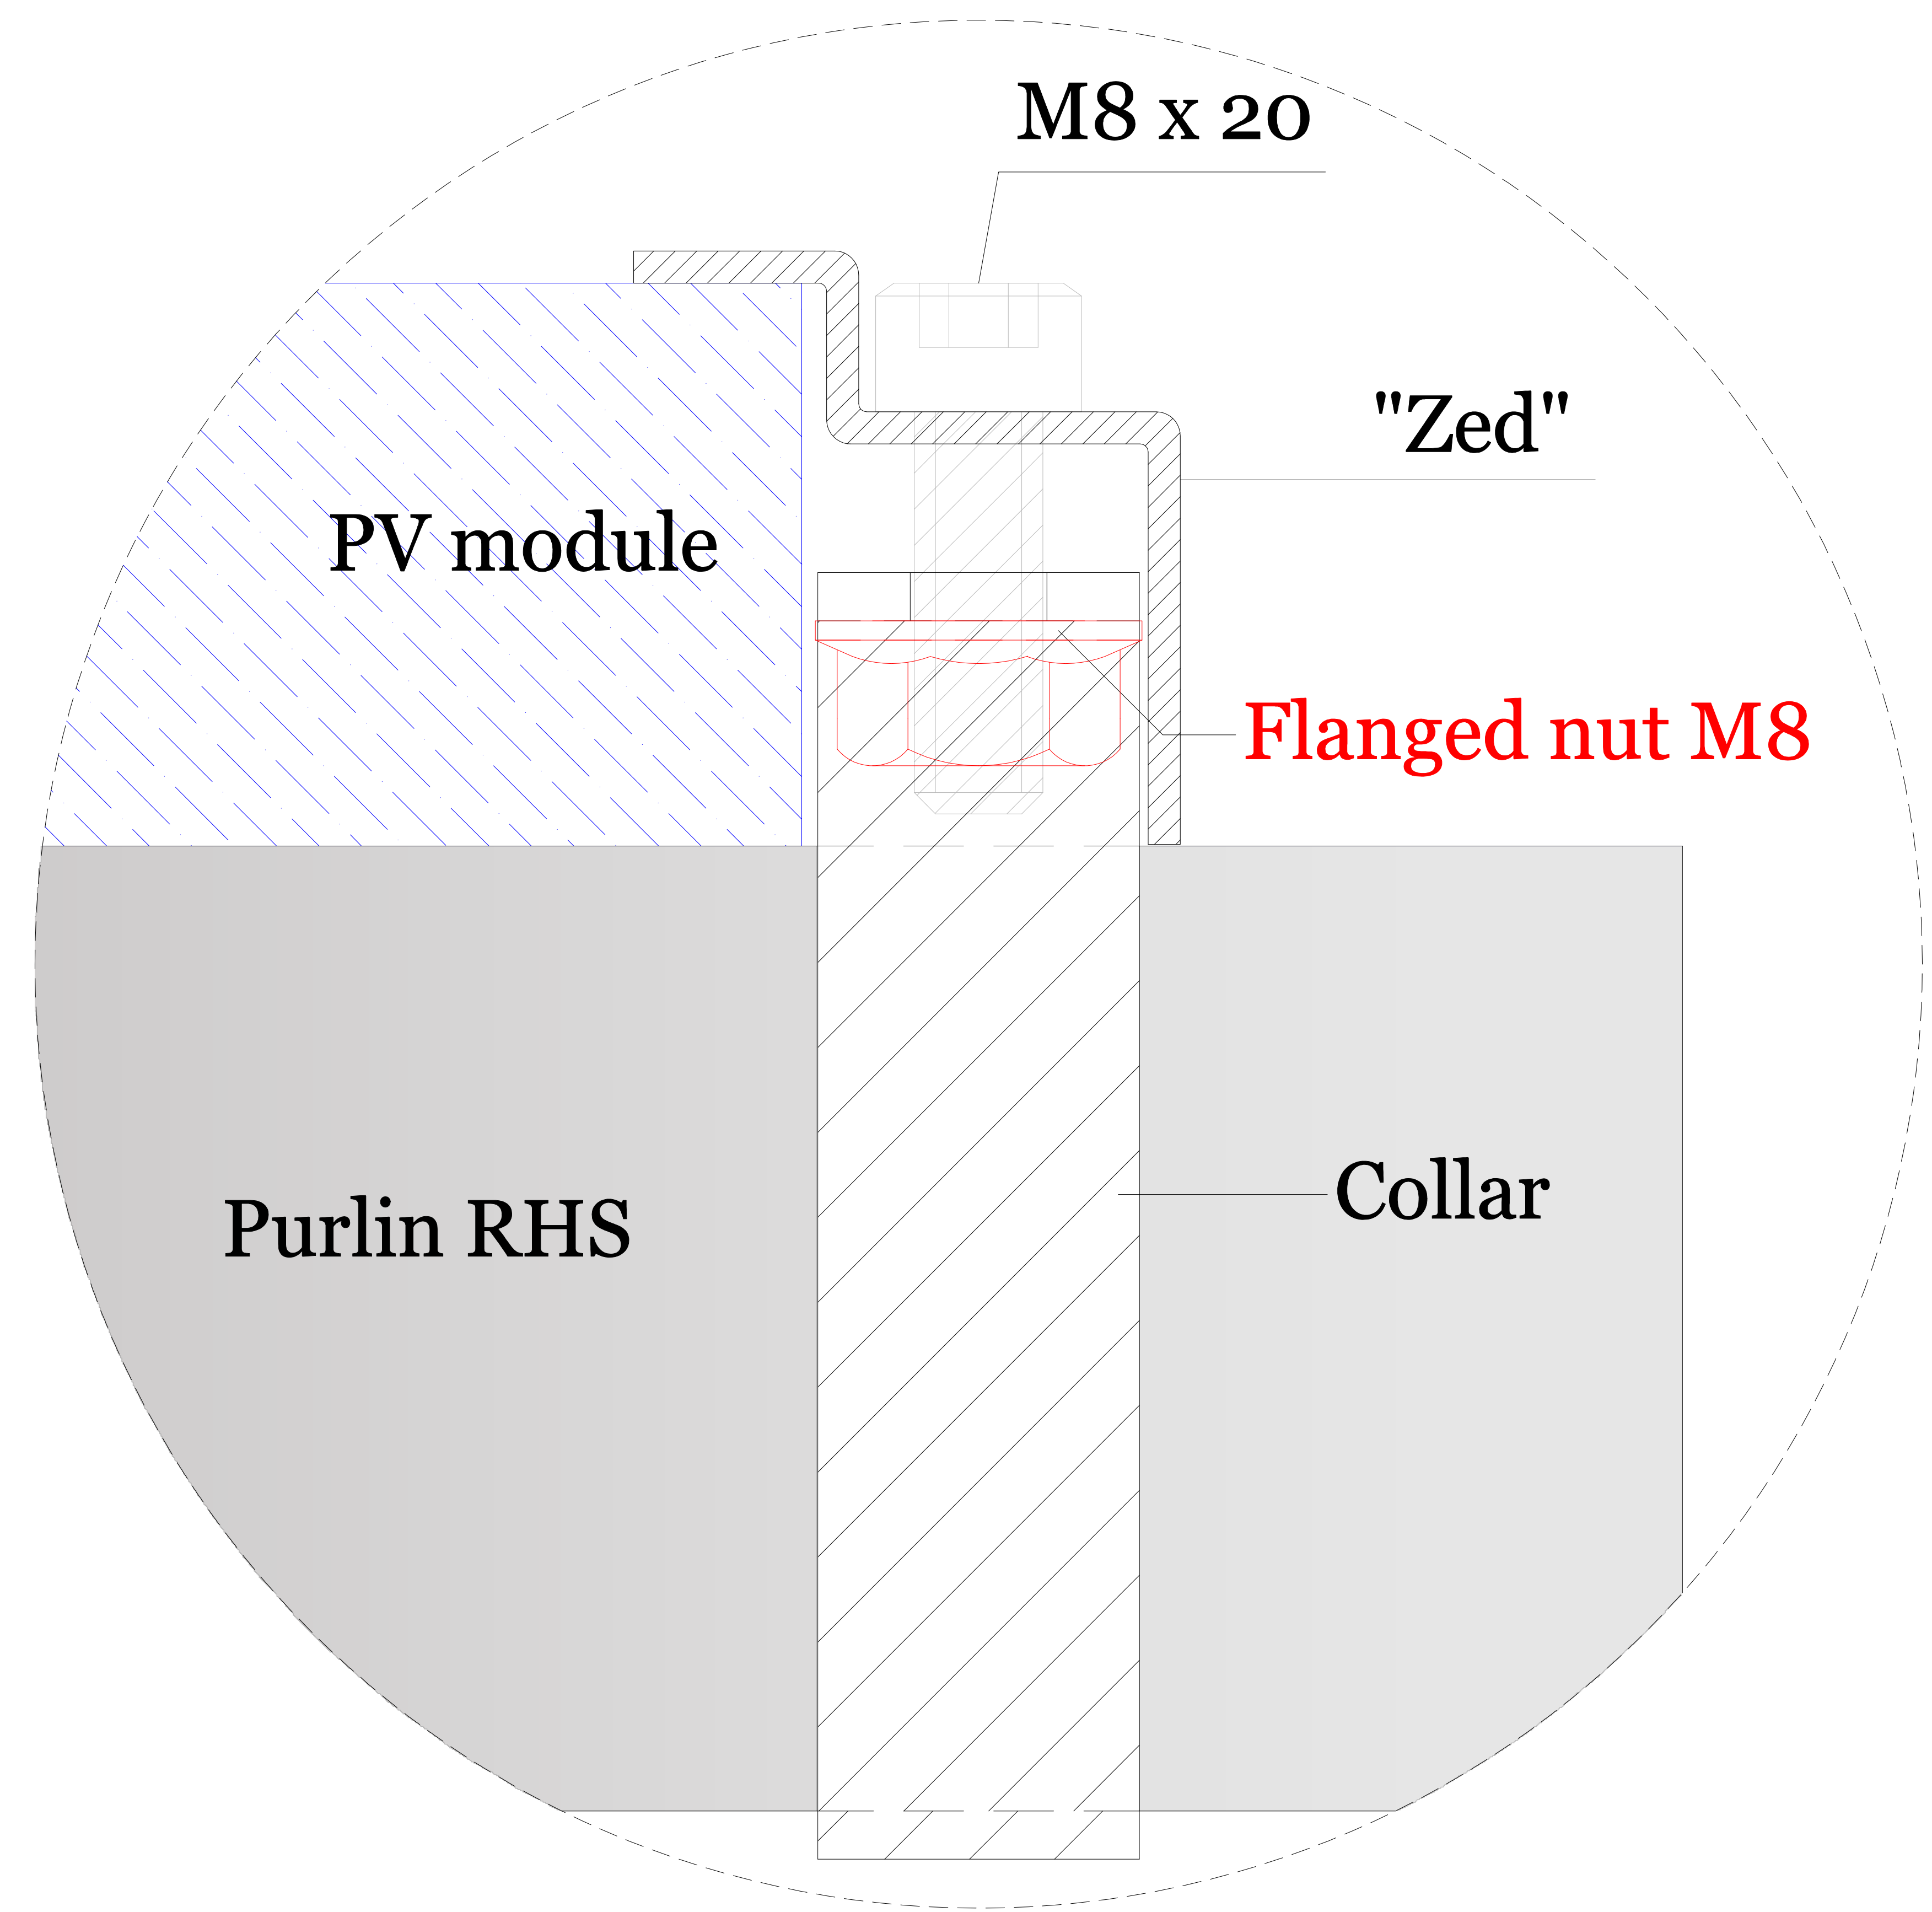

PERMITTED TIGHTENING TORQUE OF MAX 10 Nm (to be verified with the prescriptions of the module manufacturer).

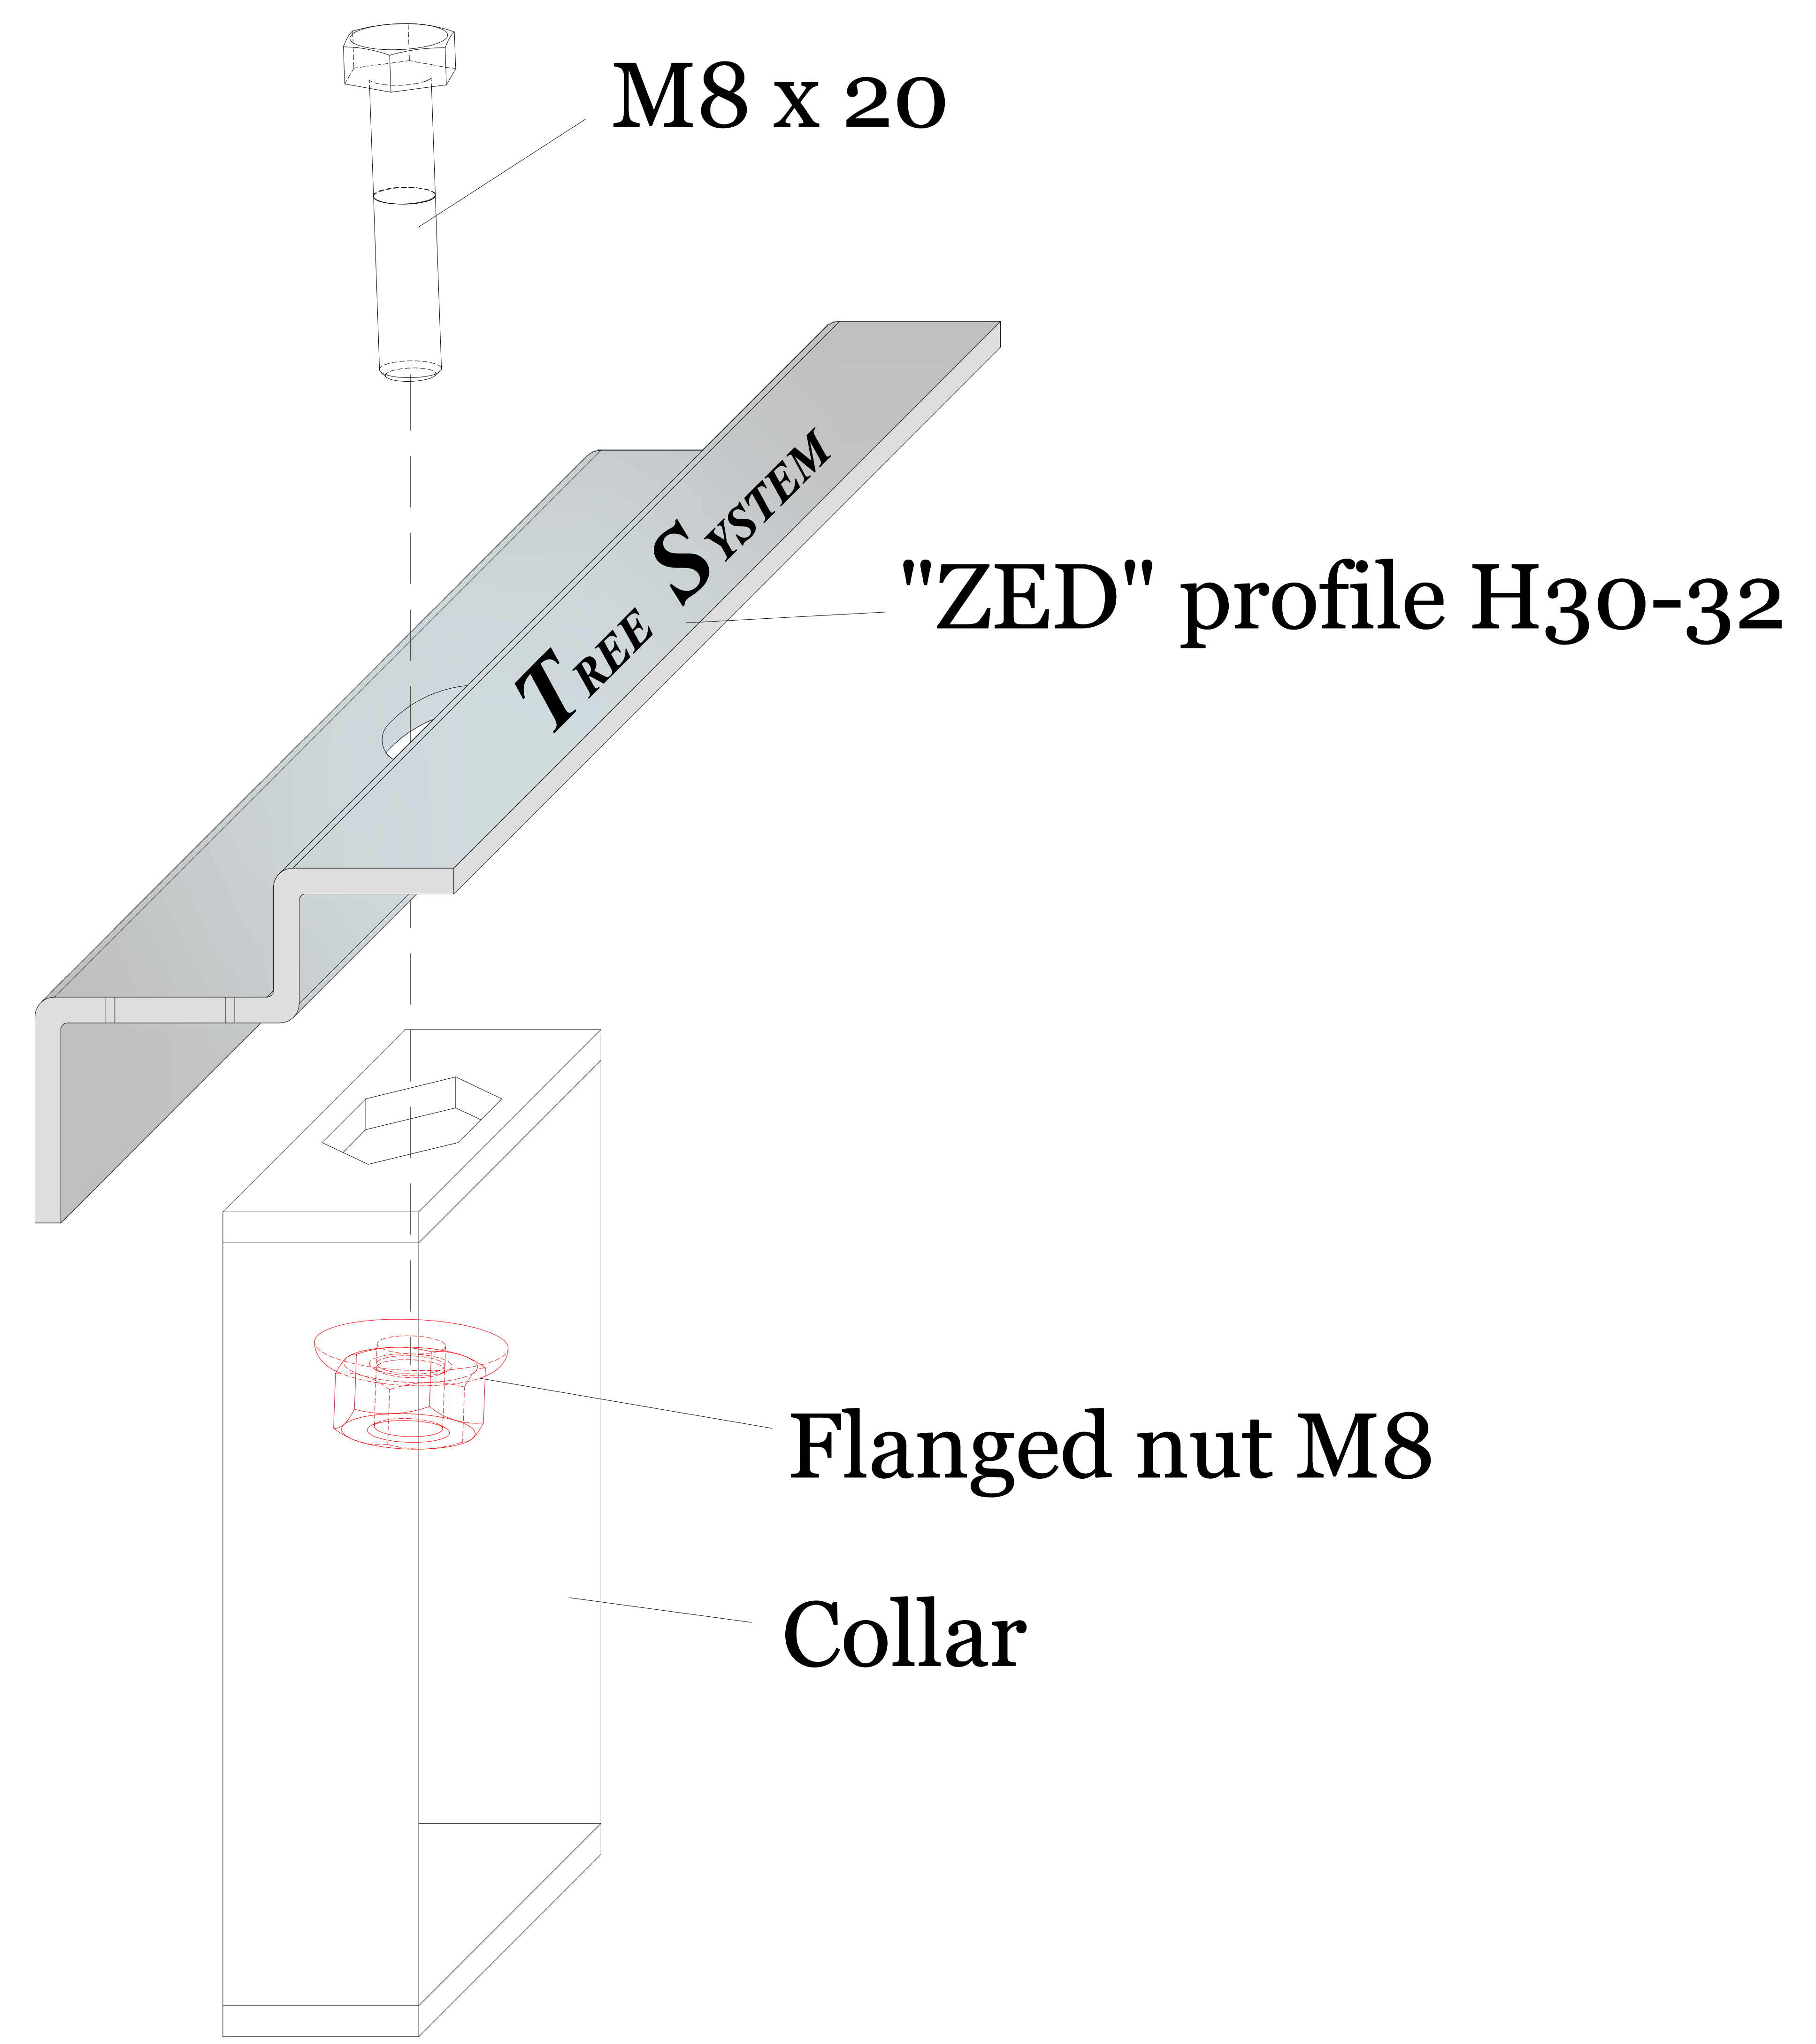

	NAME	DATE
DRAWN	M. T.	30/11/2020
CHECKED	E. B.	28/01/2021
MODIFIED	M. T.	03/03/2021



Via Morano n°22, 35020, Pozzonovo (PD)
Tel/Fax +390429773082

ethical power

Netley North PV - Southampton
5103 kWp PV power plant

TITLE
Fastening for photovoltaic modules.

SIZE DWG NO **15** REV

SCALE: WEIGHT: SHEET